



NOTE :-

1. ALL DIMENSIONS ARE IN METRE.
2. DO NOT SCALE THIS DRAWING.
3. THIS DRAWING MUST BE READ IN CONJUNCTION WITH ALL OTHER RELEVANT DRAWINGS.

NO.	DATE	DESCRIPTION	REV. BY	CHK. BY

PROJECT : **CONSTRUCTION OF 138 LAC LITRE SUMP - PUMP HOUSE AND MISCELLANEOUS WORK AT RAIL NAGAR IN RAJKOT AREA.**

CLIENT : **RAJKOT MUNICIPAL CORPORATION**
RAJKOT


CONSULTANT : **Multi Media Consultants Pvt. Ltd.**
401, Shivaji Shiksha Bhawan Cross Road, S.G. Highway,
Ahmedabad - 380 014.

TITLE : **LAYOUT PLAN OF 138 LAC LITRE SUMP & PUMP HOUSE IN WARD NO-03 - F.P NO-26A-22A - TFS NO-09 AT RAIL NAGAR**

DRAWN BY: **DHARM PRADHAN** DESIGNED BY: **V. D. BHATT** CHECKED BY: **A. N. P.**

SER. NO.: **PWC/RAIL NAGAR/001** SKD. NO.: SHEET: **1 OF 1**

SCALE: **AS SHOWN** DATE: **06/01/2024** PROJ. NO.: REVISION: **RS**

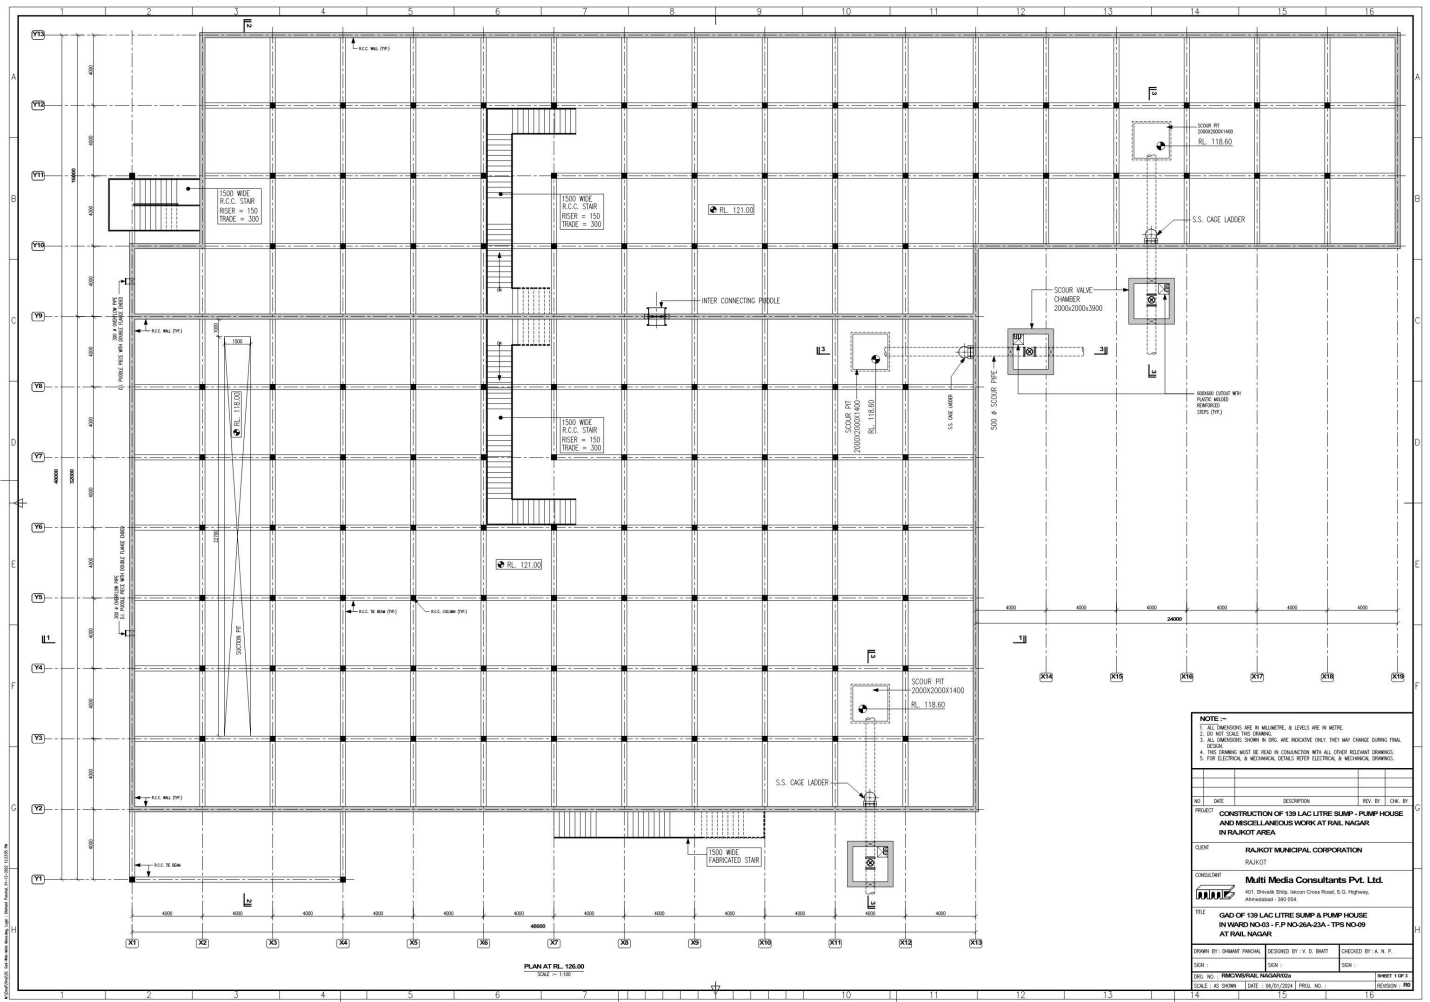

NOTE:-

1. ALL DIMENSIONS ARE IN MILLIMETRE, M LEVELS ARE IN METRE.
2. DO NOT SCALE THE DRAWING.
3. ALL DIMENSIONS GIVEN IN DIM. ARE INDICATED ONLY THEY MAY VARY DURING THE CONSTRUCTION.
4. THE DRAWING MUST BE READ IN CONJUNCTION WITH ALL OTHER RELATED DRAWINGS.
5. FOR ELECTRICAL & MECHANICAL DETAILS REFER ELECTRICAL & MECHANICAL DRAWINGS.

NO.	DATE	DESCRIPTION	REV. BY	CHK. BY


PROJECT: CONSTRUCTION OF 130 LAC LITRE SLUMP - PUMP HOUSE AND MISCELLANEOUS WORK AT RAIL NAGAR INFRA-NOT AREA

SUPPLY: RAJNAND MUNICIPAL CORPORATION RAJNAND

CONSULTANT: Multi Media Consultants Pvt. Ltd.
401, Shreebh. Shree. Mahan Cross Road, S.G. Highway, Anandnagar, 388 204.

TITLE: CAD OF 130 LAC LITRE SLUMP & PUMP HOUSE INWARD NO-03 - F.P. NO-28A-23A - TPS NO-09 AT RAIL NAGAR

DRAWN BY: SHAMSH PRADHAN	DESIGNED BY: V. D. BHATT	CHECKED BY: A. N. P.
SCALE: AS SHOWN	DATE: 06/07/2024	PROJECT NO.:
DRAWING NO.:		SHEET NO.:
SCALE: AS SHOWN		DATE: 06/07/2024
DRAWING NO.:		SHEET NO.:

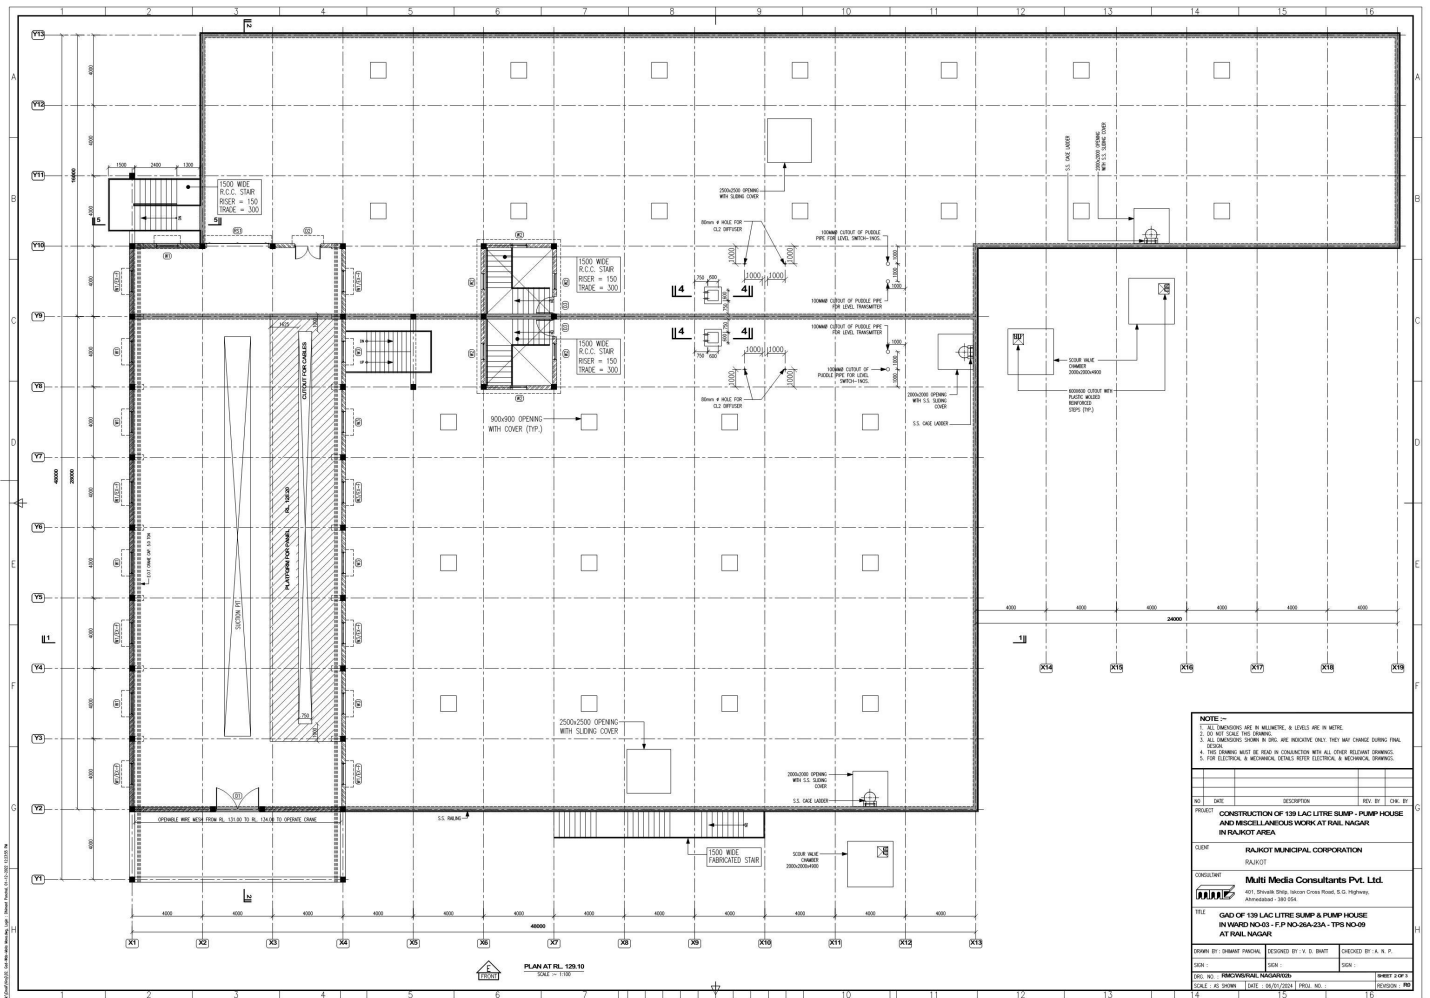

PLAN AT RL. 126.10
SCALE: 1/16" = 1'-0"

NOTE:-

1. ALL DIMENSIONS ARE IN MILLIMETER. ALL LEVELS ARE IN METRE.
2. DO NOT SCALE THE DRAWING.
3. ALL DIMENSIONS SHOWN IN DIM. ARE INDICATED ONLY. THEY MAY VARY DURING THE CONSTRUCTION.
4. THE DRAWING MUST BE READ IN CONJUNCTION WITH ALL OTHER RELATED DRAWINGS.
5. FOR ELECTRICAL & MECHANICAL DETAILS REFER ELECTRICAL & MECHANICAL DRAWINGS.

NO.	DATE	DESCRIPTION	REV. BY	CHK. BY


PROJECT: CONSTRUCTION OF 130 LAC LITRE SLUMP - PUMP HOUSE AND MISCELLANEOUS WORK AT RAIL NAGAR INFRAKOT AREA

SUPPLIER: RAJNAND MUNICIPAL CORPORATION RAJNAND





CONSULTANT: Multi Media Consultants Pvt. Ltd.
401, Shreebh. Shree. Mahan Cross Road, S.G. Highway, Anandnagar, 388 204

TITLE: GAS OF 130 LAC LITRE SLUMP & PUMP HOUSE INWARD NO.43 - F.P. NO-26A-23A - T.PS NO-09 AT RAIL NAGAR

DRAWN BY: SHAMANT PRADHAN	DESIGNED BY: V. D. BHATT	CHECKED BY: A. A. P.
SCALE: AS SHOWN	DATE: 06/07/2024	PROJECT NO: 130

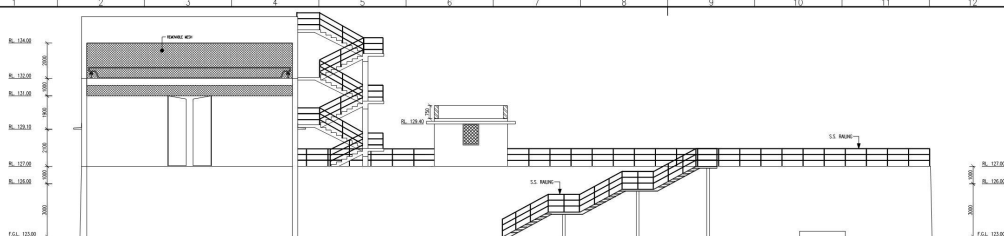

R.C.C. STAIR DETAILS			
WIDTH OF R.C.C. STAIR-1500MM		} SPECIFICATIONS AS PER CONTRACT	
TRADE = 300 MM			
RISER = 150 MM			
SCHEDULE OF OPENING (PUMP HOUSE)			
MKD.	SIZE	SILL HT. T. NO.	REMARK
D1	1500 X 3000	—	} SPECIFICATIONS AS PER CONTRACT
D2	2500 X 3000	—	
D3	1500 X 3000	—	
D4	1000 X 2100	—	
W1	1000 X 1300	0900	
W2	1000 X 1300	1000	
W3	1300 X 1300	2100	06
LX-1	300 X 300	DEAD BOTT	08

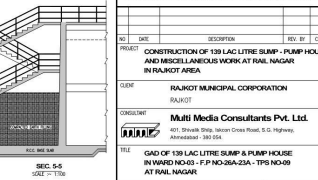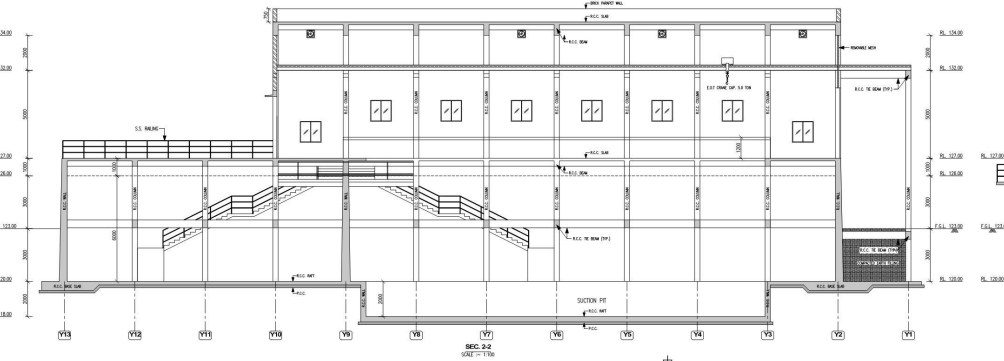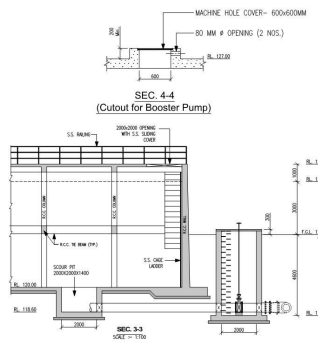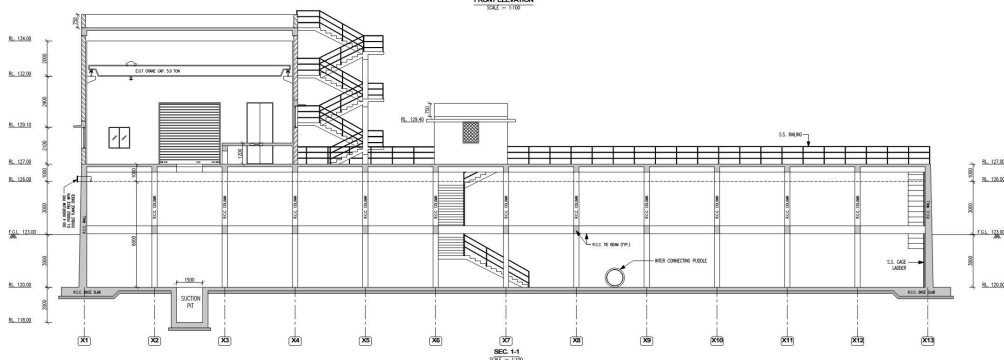

NOTE:-

- ALL DIMENSIONS ARE IN MILLIMETRE, UNLESS ARE IN METRE.
- DO NOT SCALE THE DRAWING.
- ALL DIMENSIONS GIVEN IN DIM. ARE INDICATED ONLY, THEY MAY VARY DURING THE CONSTRUCTION.
- THE DRAWING MUST BE USED IN CONJUNCTION WITH ALL OTHER RELATED DRAWINGS.
- FOR ELECTRICAL & MECHANICAL DETAILS REFER ELECTRICAL & MECHANICAL DRAWINGS.

NO.	DATE	DESCRIPTION	REV. BY	CHK. BY

PROJECT: CONSTRUCTION OF 150 LAC LITRE SLUMP - PUMP HOUSE AND MISCELLANEOUS WORK AT RAIL NAGAR INFRASTRUCTURE AREA

SUPPLIER: RAJNAND MUNICIPAL CORPORATION RAJNAND

CONSULTANT: Multi Media Consultants Pvt. Ltd.
401, Shreebh. Shree. Mahan. Cross Road, S.G. Highway, Anandnagar, 388 204.

TITLE: GAD OF 150 LAC LITRE SLUMP & PUMP HOUSE IN VARD NAGAR - P.P NO-28A-23A - TPS NO-09 AT RAIL NAGAR

DRAWN BY: SHAMSHIRI PRADHAN DESIGNED BY: V. D. BHATT CHECKED BY: A. N. P.

DATE: 28/07/2024 SHEET NO. 11 OF 11

SCALE: AS SHOWN DATE: 28/07/2024 PROJ. NO. SECTION: 11